


Dimensions are not to be scaled from this drawing.



Calculation Summary								
Label	CalcType	Units	Avg	Max	Min	Min/Avg	Min/Max	Grid Z
Room_Workplane	Illuminance	Lux	324.46	385	239	0.74	0.62	0.7

Room Summary			
Label	Type	Wall Ht.	Description
Warehouse	Rect-Gable	6.5m	High Dirt Build Up, 3 Year Surface Cleaning, Reflectances (C, W, F) : 0.8, 0.5, 0.2

Luminaire Schedule									
Symbol	Qty	Label	Arrangement	Total Lamp Lumens	LLF	Description	LLD	LDD	RSD
⊙	65	A	SINGLE	26938	0.609	250W LED High Bay mounted at 5.8m (2 Year cleaning cycle)	0.800	0.810	0.940

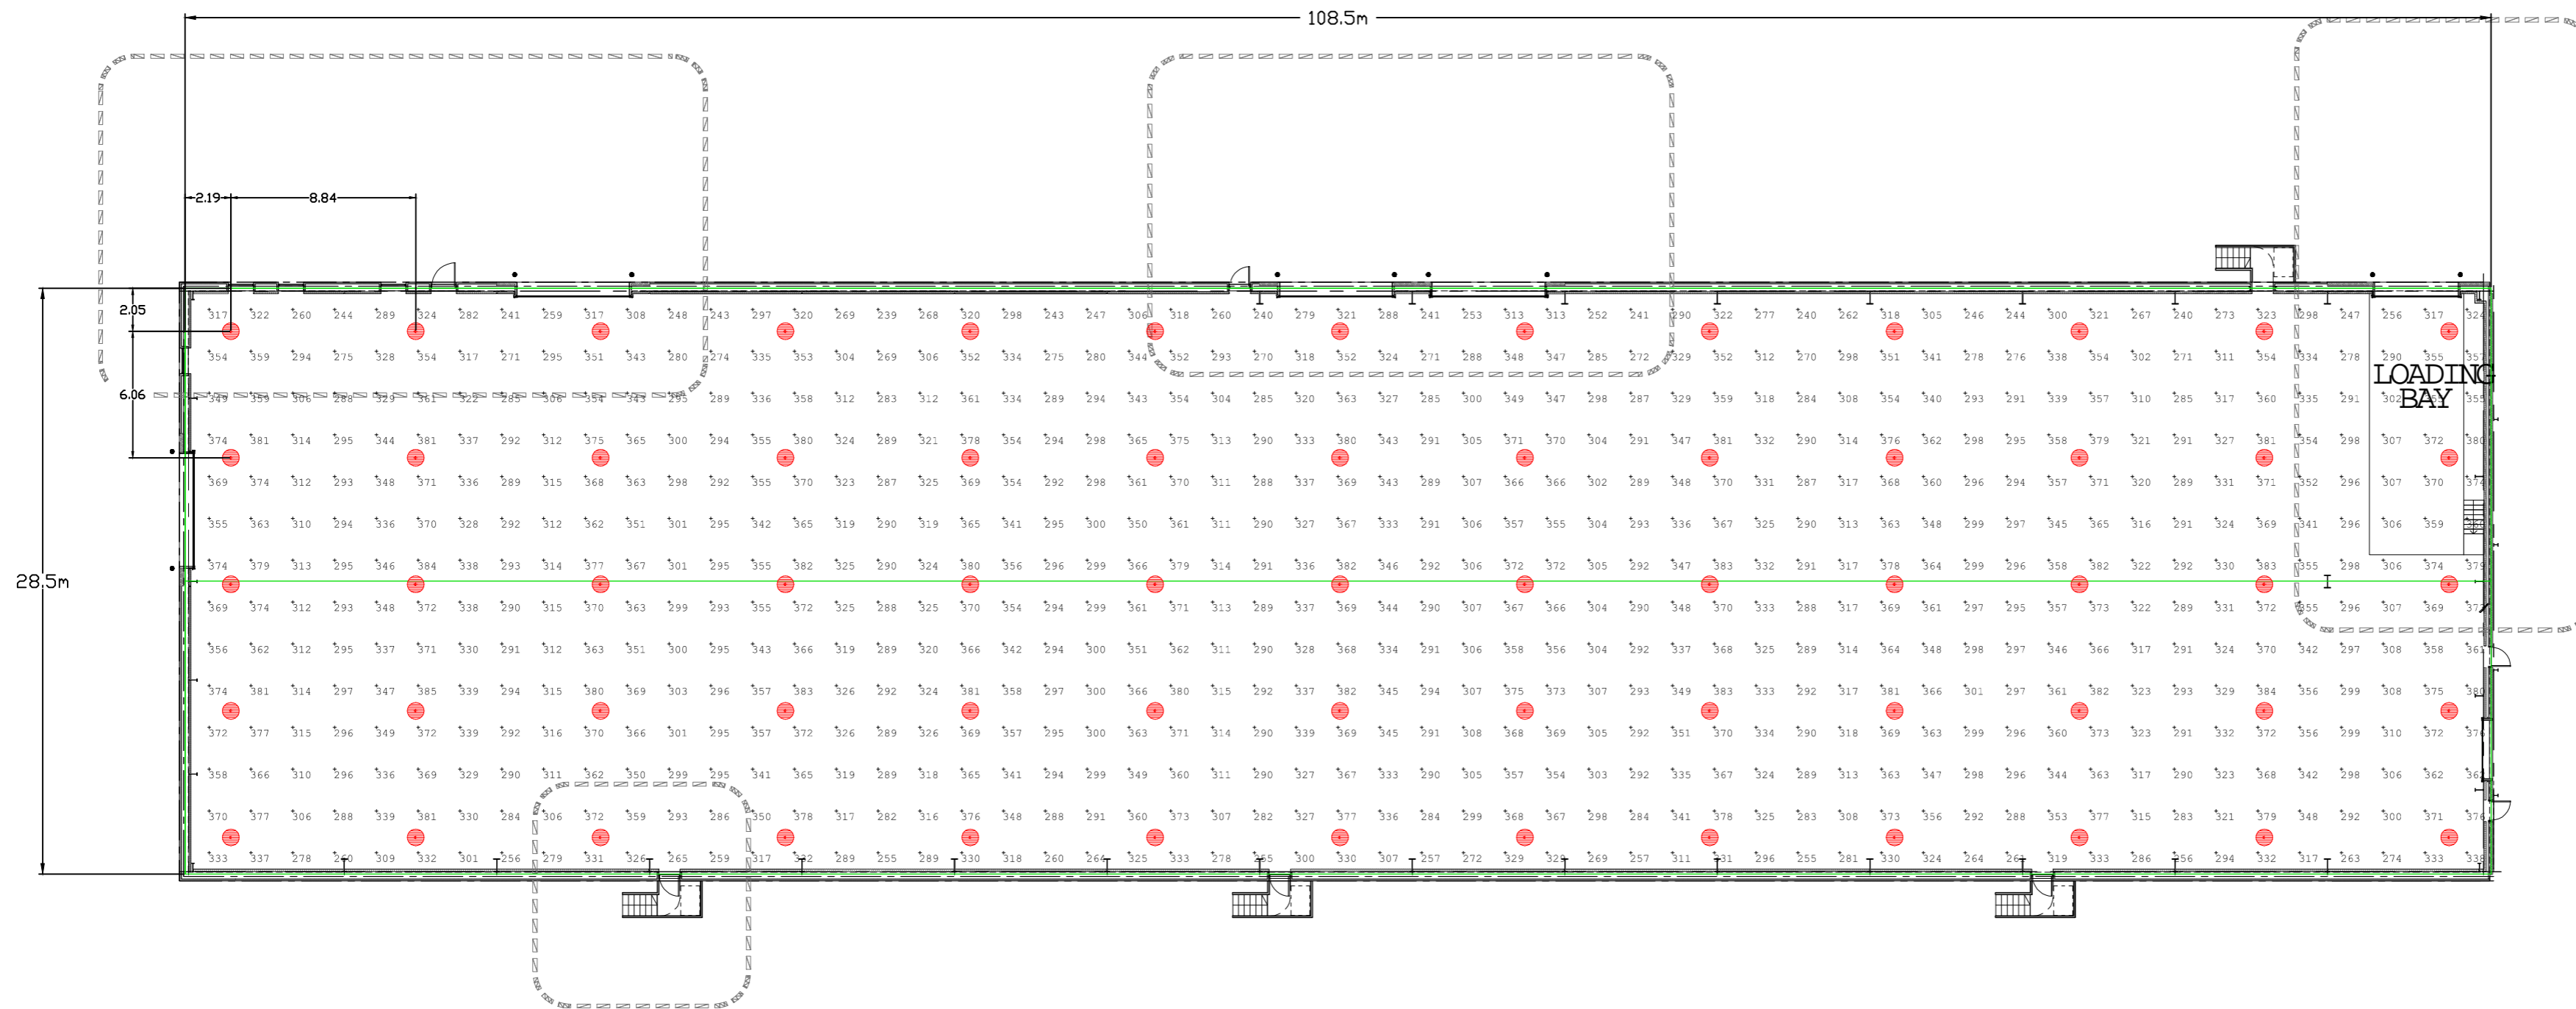

Members Of



Contact Details
 Retcher Way, Dream Farm Industrial Park, Mansfield, Nottinghamshire, NG20 9PZ
 Design Telephone 01623 415 904 Fax 01623 415 903
 Email: lighting@kingfisherlighting.com
 Web: www.kingfisherlighting.com

Project Title
 28m x 110m x 6.5m Gable end warehouse

Scale
 1:250 at A2
 Project No
 Sample warehouse

Date
 17/4/2015
 Drawing No
 300lx/28/110/6.5

A lighting applications design service is provided by us in good faith and without charge, relating to Kingfisher products only. As such, whilst every endeavour is made for accuracy from information provided by yourselves, the final responsibility for the suitability of the design lies with the client. The company cannot, therefore, accept any liability or consequential loss incurred.